


- CABLE LEGEND
- ① (3) 2 1/2" PVC - 3#300KCM(KL,HHW)
 - ② 1.25" EMT - 3#3(CU,THHN)+1#6(CU,THHN)SND

ONE-LINE DIAGRAM

NOT TO SCALE

ELECTRICAL ONE LINE DIAGRAM BLD "C"

N.T.S.

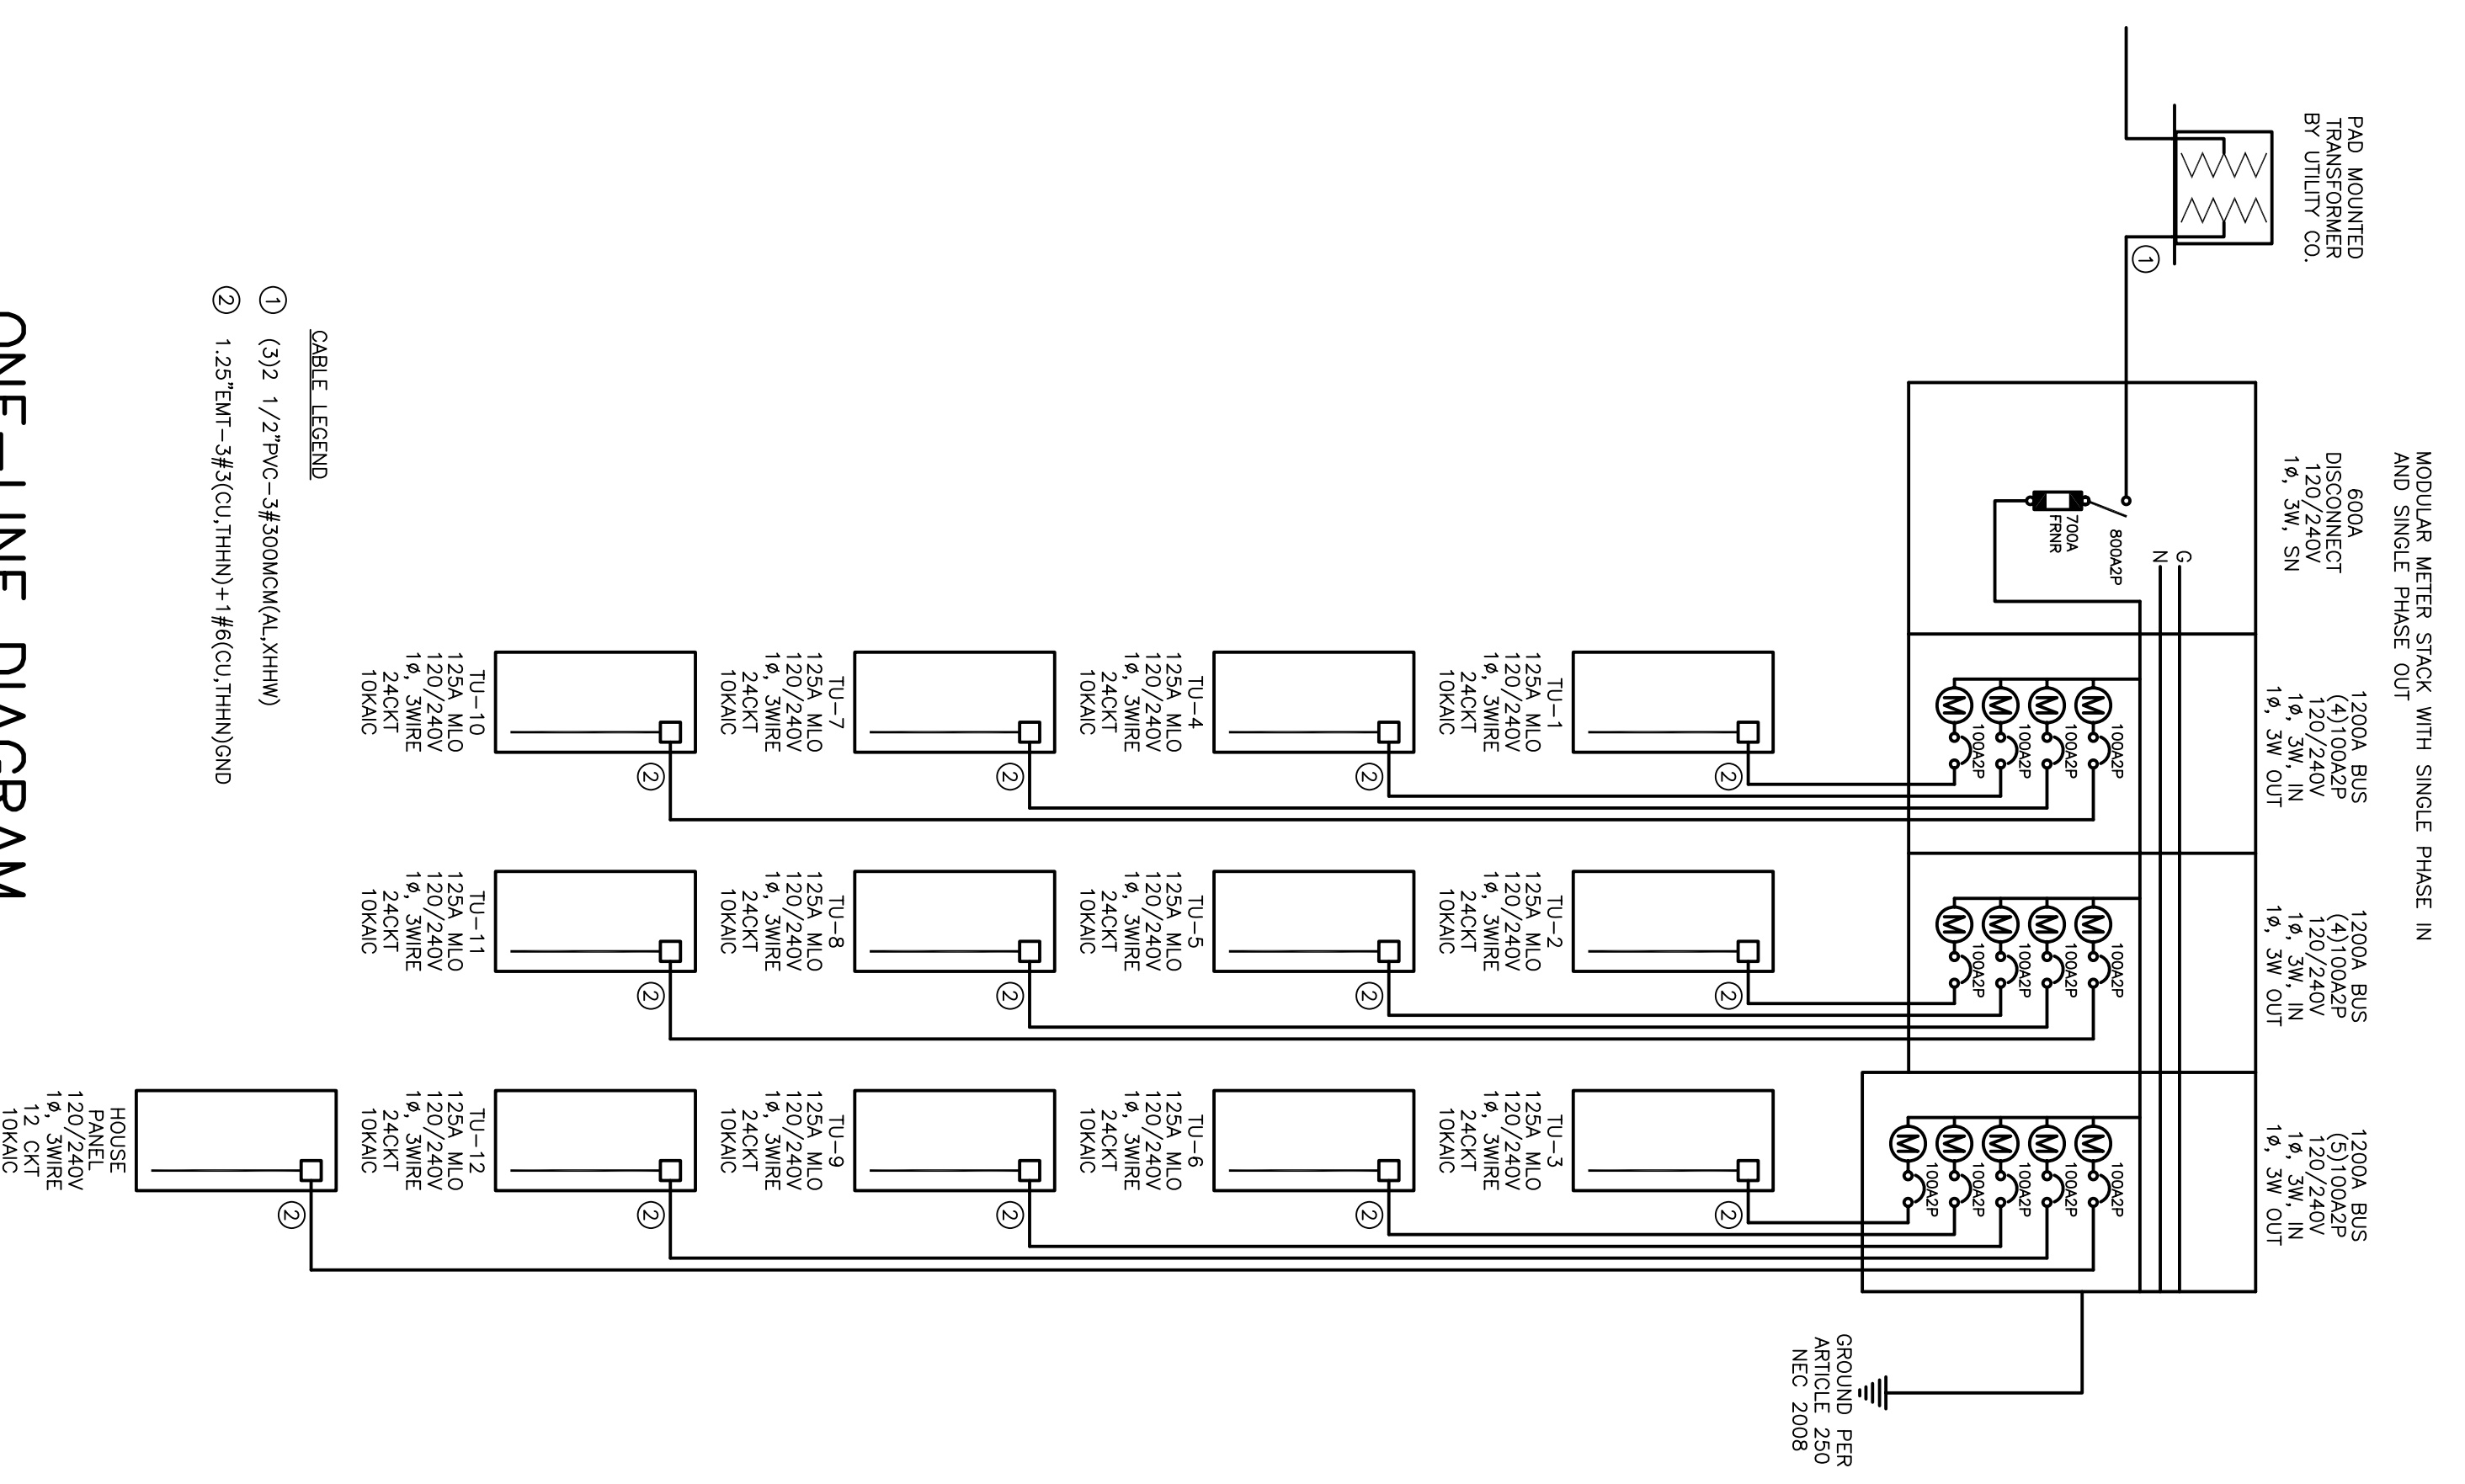


- CABLE LEGEND
- ① (3) 2 1/2" PVC - 3#300KCM(KL,HHW)
 - ② 1.25" EMT - 3#3(CU,THHN)+1#6(CU,THHN)SND

ONE-LINE DIAGRAM

NOT TO SCALE

ELECTRICAL ONE LINE DIAGRAM BLD "A"

N.T.S.

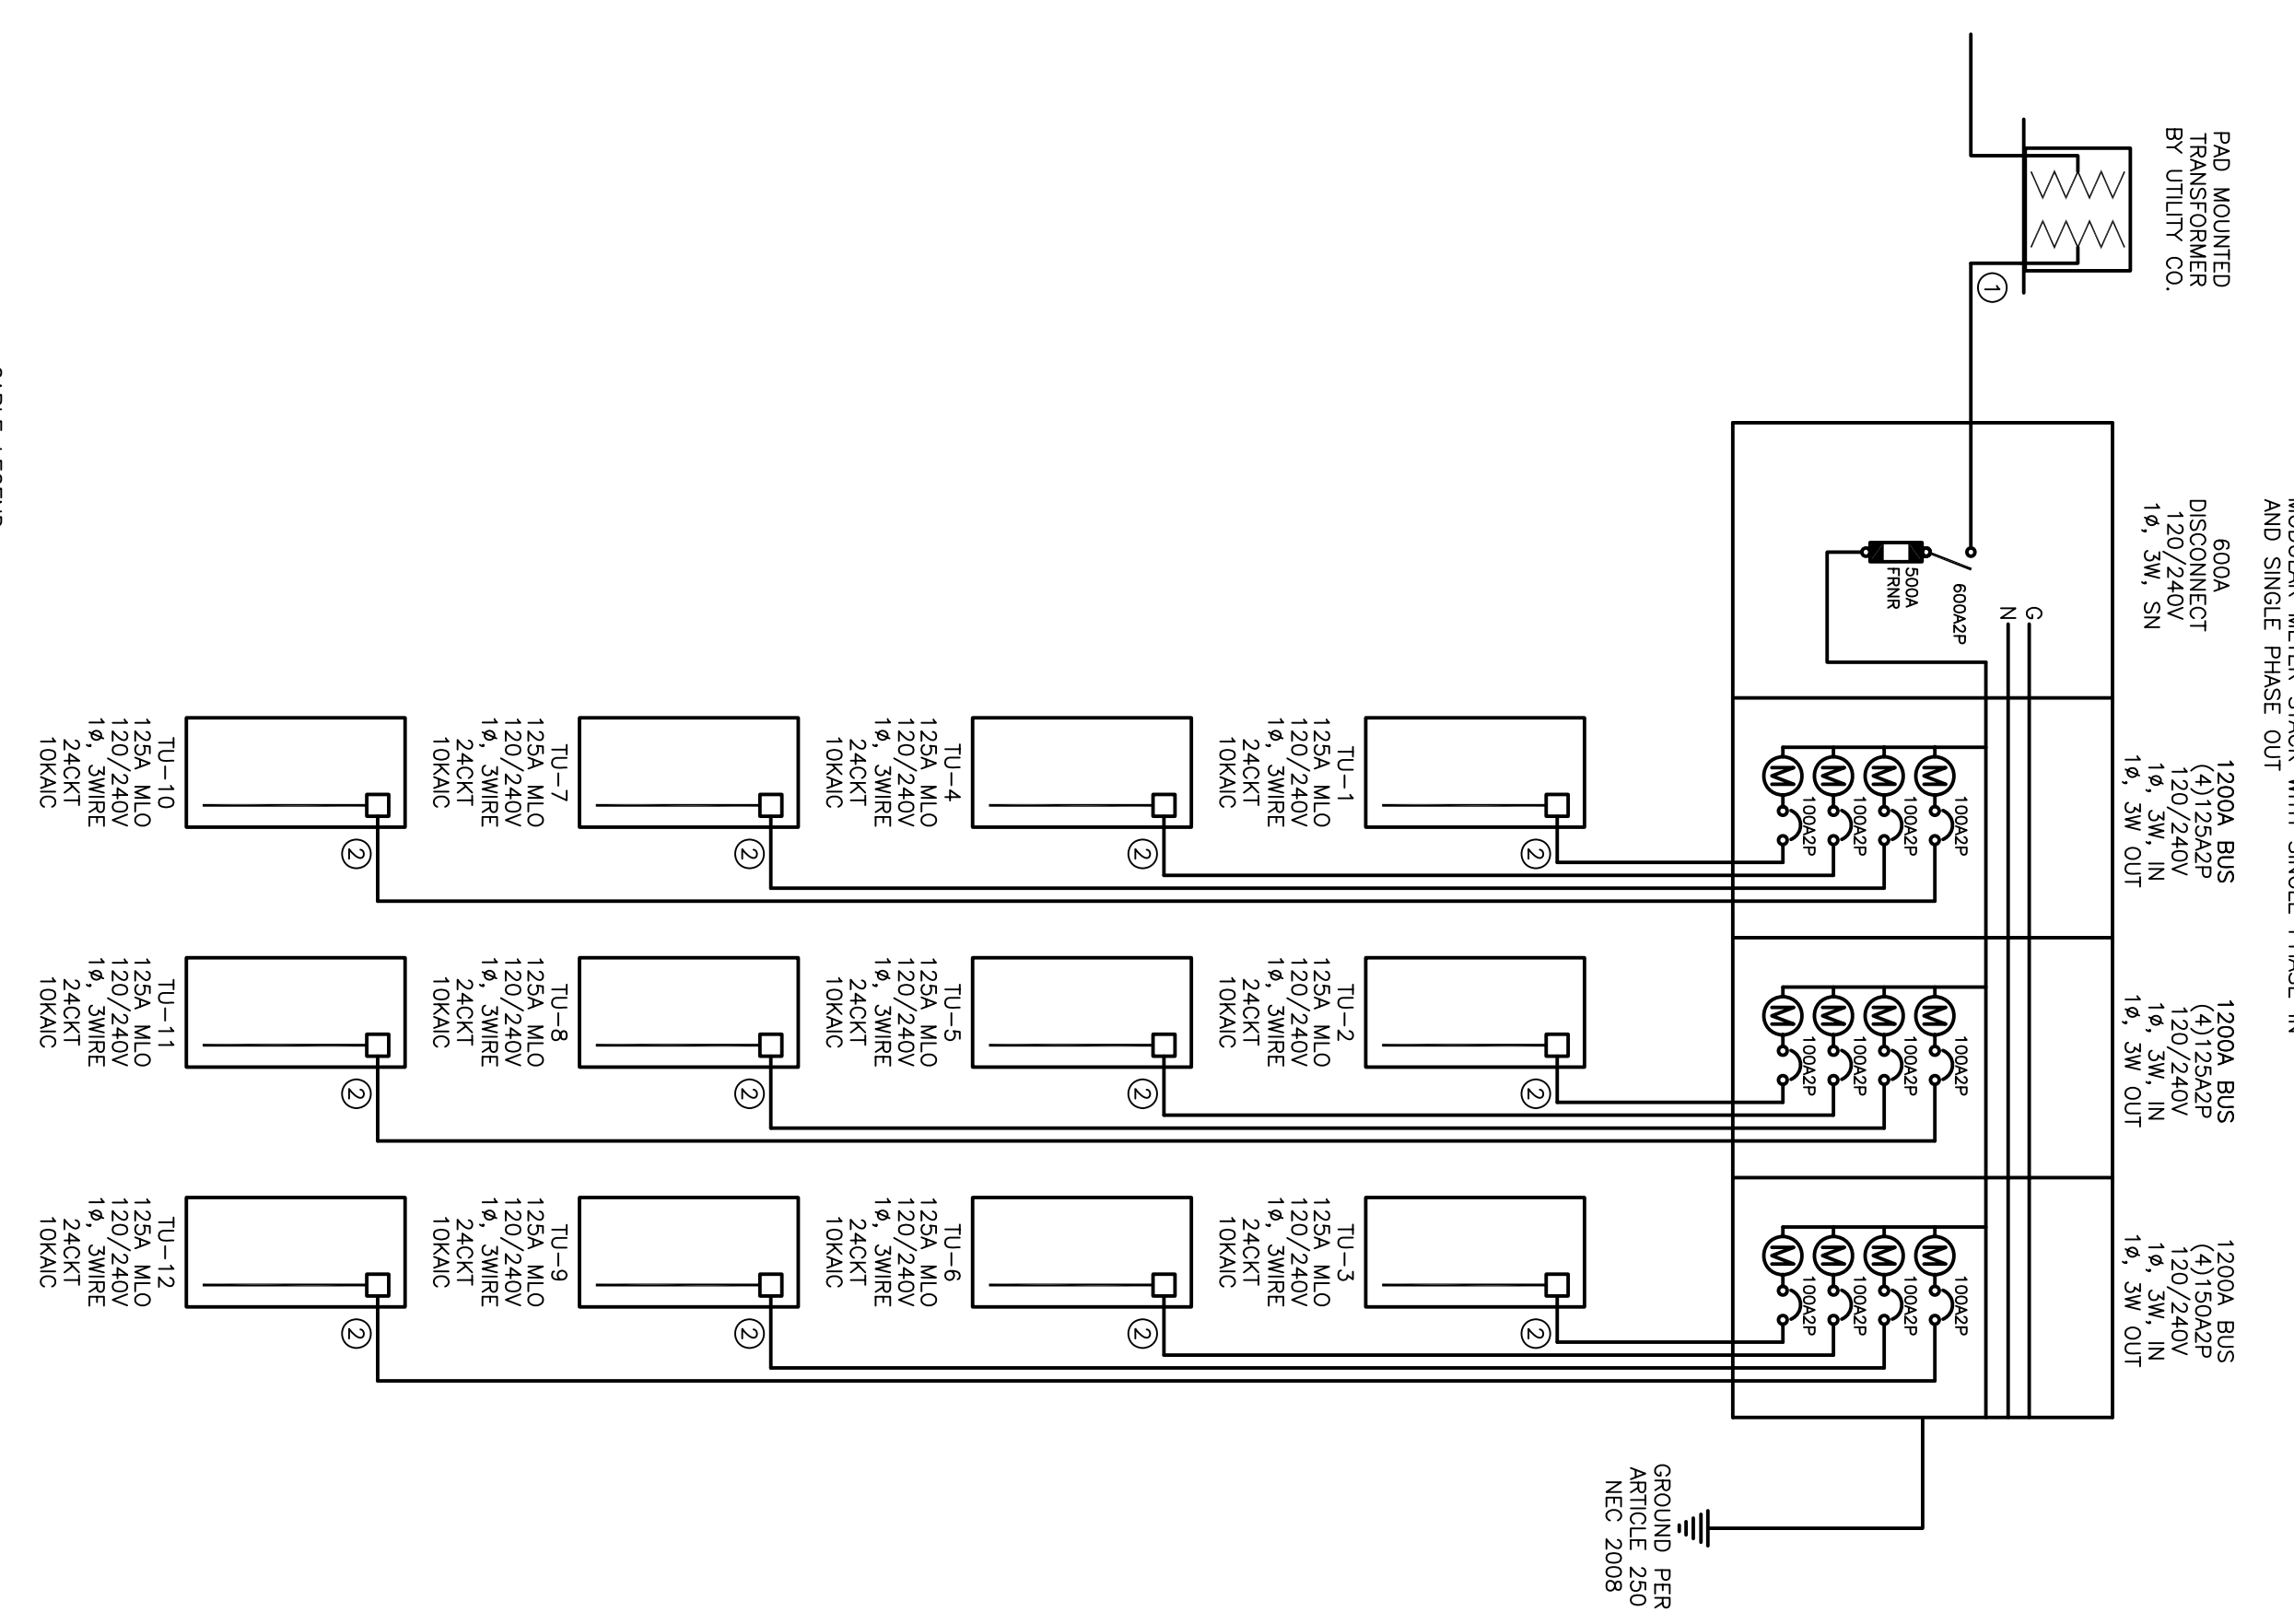

- CABLE LEGEND
- ① (3) 2 1/2" PVC - 3#250KCM(KL,HHW)
 - ② 1.25" EMT - 3#3(CU,THHN)+1#6(CU,THHN)SND


ONE-LINE DIAGRAM

NOT TO SCALE

ELECTRICAL ONE LINE DIAGRAM BLD "D" & "G"

N.T.S.

DO NOT REPRODUCE THESE DRAWINGS AND INFORMATION WITHOUT THE WRITTEN PERMISSION OF THE ENGINEER. THE ENGINEER AND SOCIAL SHALL REMAIN THE RESPONSIBLE OF THE ENGINEER'S DESIGN AND THE CONTRACTOR'S OBLIGATION IS TO FOLLOW THE CONTRACT DOCUMENTS AND NOT THESE DRAWINGS. THE CONTRACTOR SHALL BE RESPONSIBLE FOR OBTAINING ALL NECESSARY PERMITS AND APPROVALS FROM THE APPROPRIATE AGENCIES. THE CONTRACTOR SHALL BE RESPONSIBLE FOR THE PROTECTION OF ALL UTILITIES AND STRUCTURES EXISTING ON THE SITE. THE CONTRACTOR SHALL BE RESPONSIBLE FOR THE PROTECTION OF ALL EXISTING STRUCTURES AND UTILITIES. THE CONTRACTOR SHALL BE RESPONSIBLE FOR THE PROTECTION OF ALL EXISTING STRUCTURES AND UTILITIES.

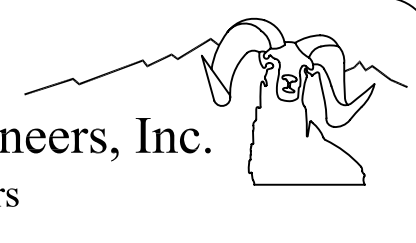

Bighorn Consulting Engineers, Inc.
 Mechanical & Electrical Engineers
 569 S. Westgate Dr., Suite 1
 Grand Junction, CO 81505
 phone: 970-241-8709, fax: 970-241-9514

UNIVERSITY VILLAGE APARTMENTS
ELECTRICAL ONE LINE DRAWINGS
 2304 NORTH 17TH STREET
 GRAND JUNCTION, COLORADO

DATE: ISSUED FOR: PERMIT
 06/07/10

DATE:	06/07/10
JOB NO.:	104079
DRAWN BY:	BRE
CHECKED BY:	AS
SCALE:	AS SHOWN
SHEET NUMBER:	E1-1