


ELECTRICAL ONE LINE DIAGRAM BLD "B"


N.T.S.

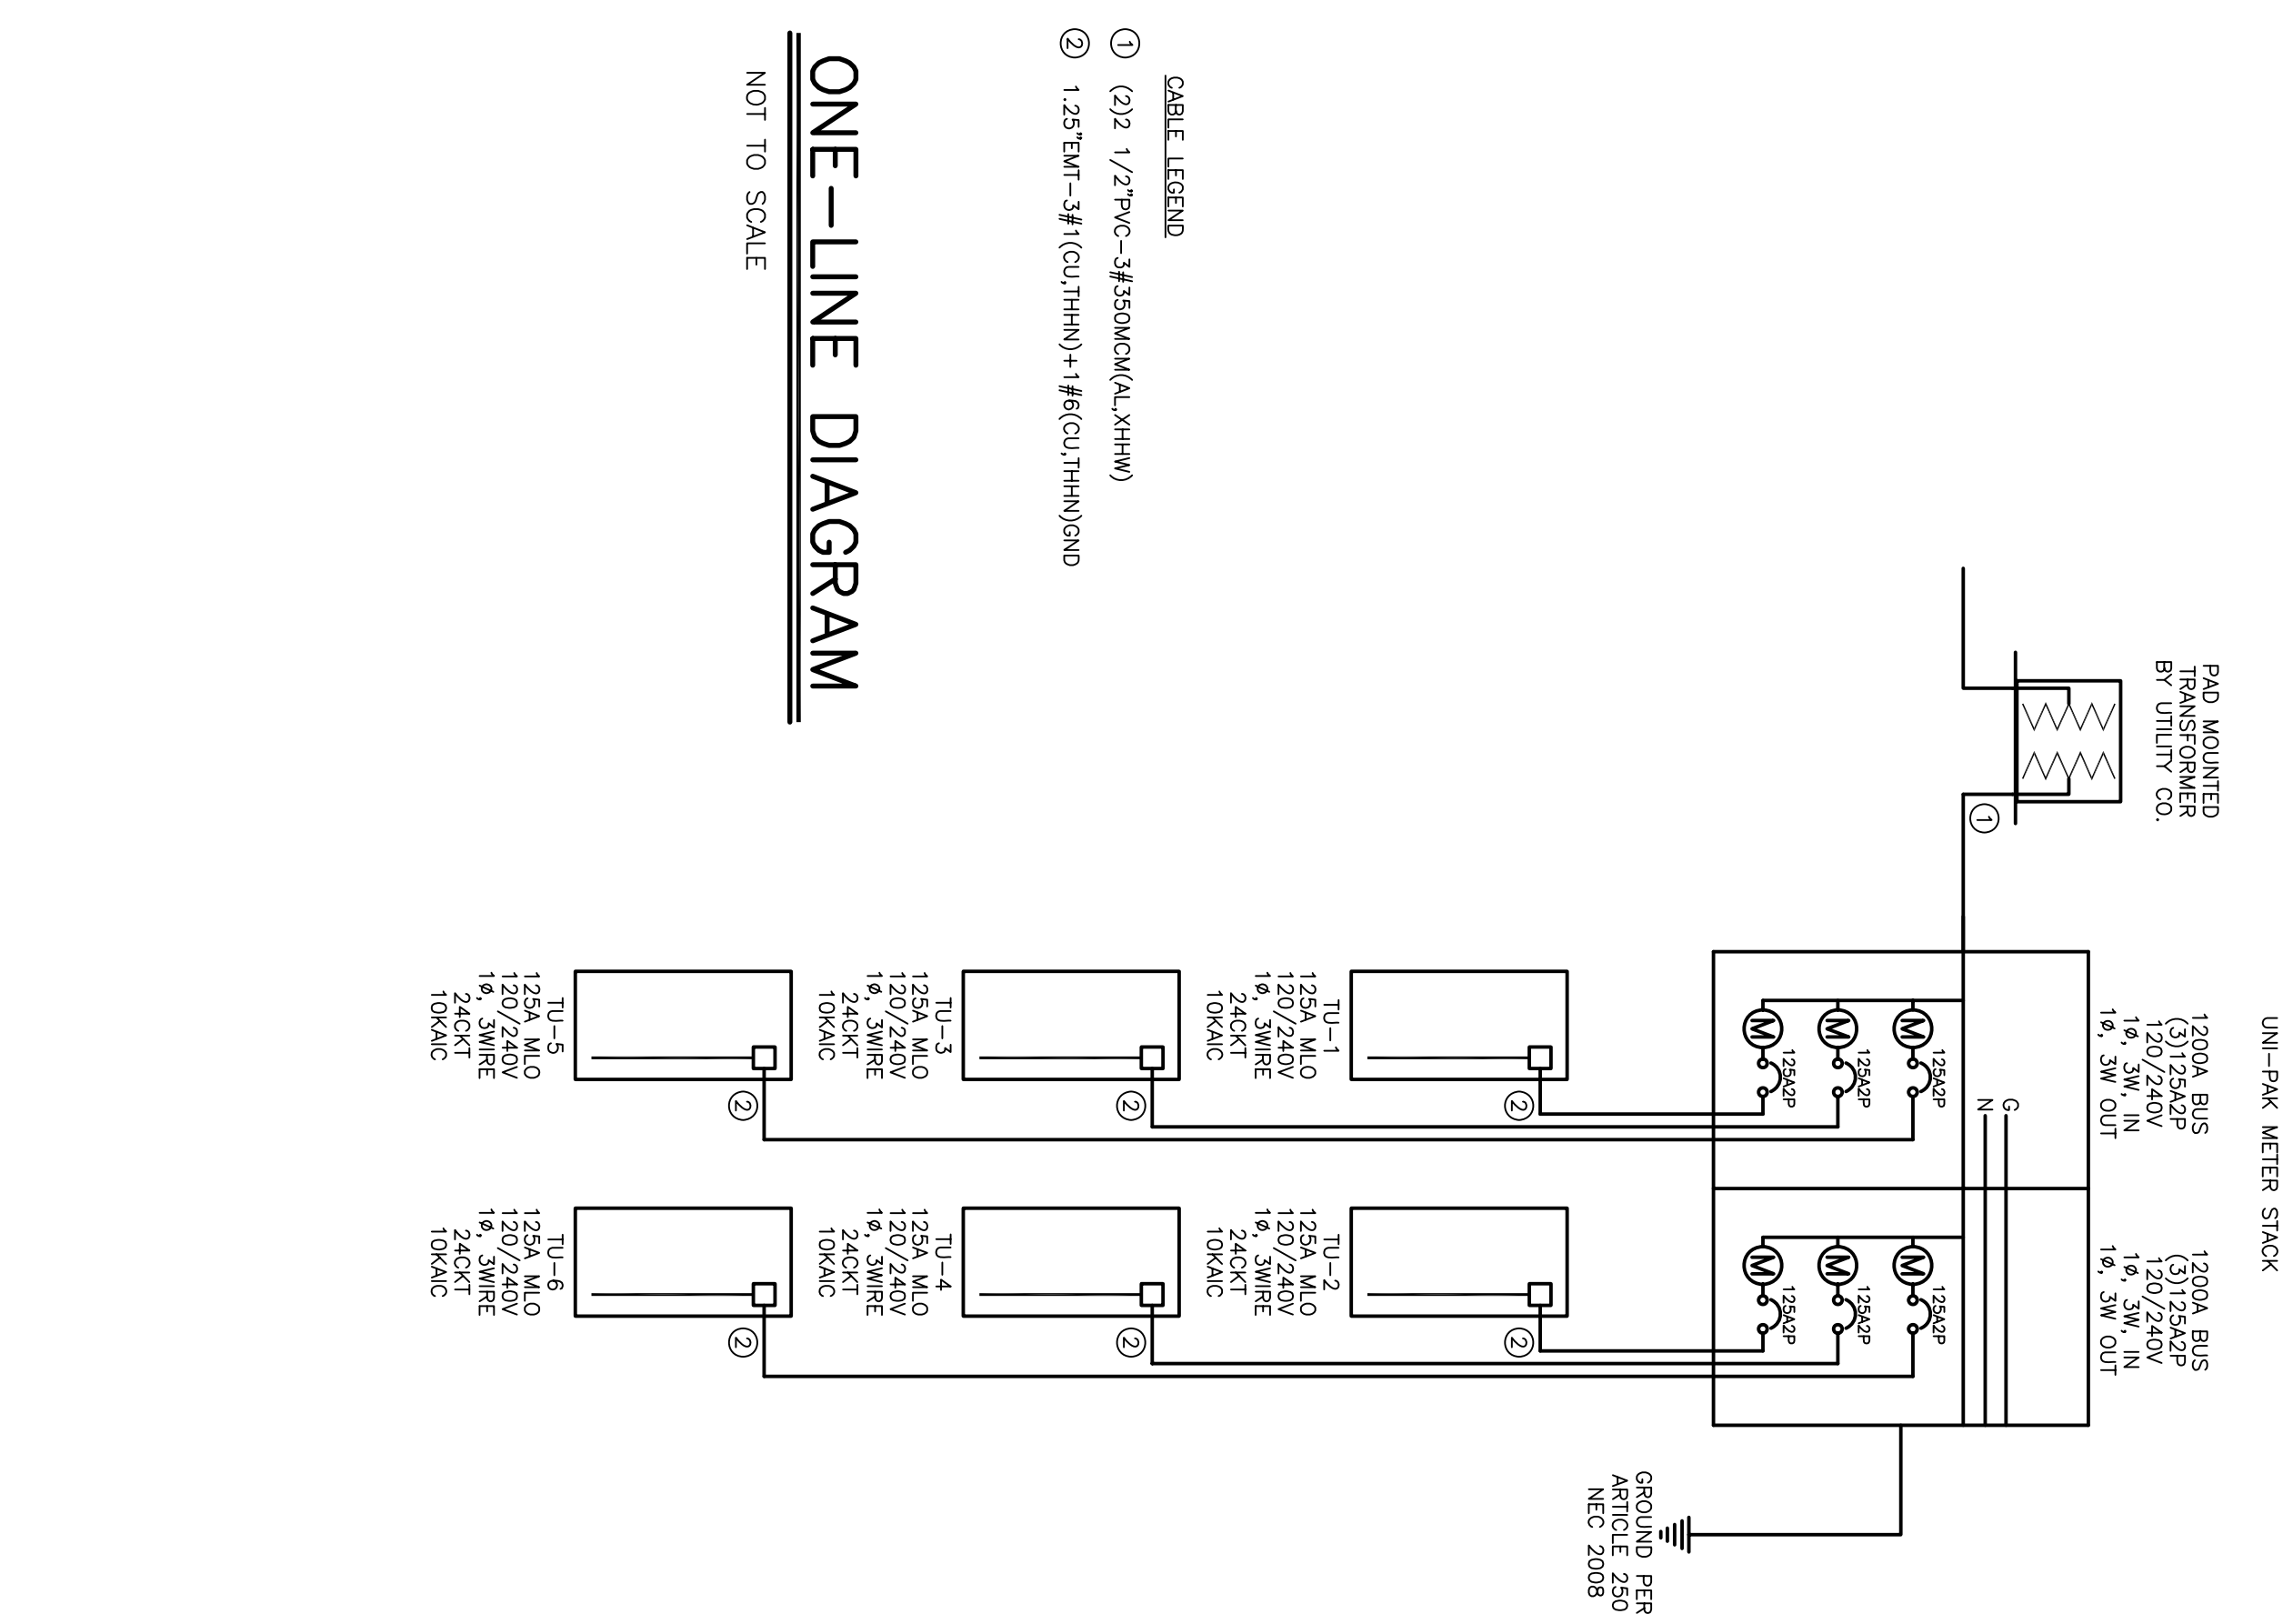

ELECTRICAL ONE LINE DIAGRAM BLD "E" & "F"

N.T.S.

DO NOT REPRODUCE THESE DRAWINGS AND INFORMATION WITHOUT THE WRITTEN PERMISSION OF THE ENGINEER. THE ENGINEER AND SOCIAL AGENT SHALL BE RESPONSIBLE FOR THE DESIGN AND CONSTRUCTION OF THE PROJECT. THE ENGINEER'S LIABILITY IS LIMITED TO THE DESIGN AND CONSTRUCTION OF THE PROJECT. THE ENGINEER'S LIABILITY IS LIMITED TO THE DESIGN AND CONSTRUCTION OF THE PROJECT. THE ENGINEER'S LIABILITY IS LIMITED TO THE DESIGN AND CONSTRUCTION OF THE PROJECT.

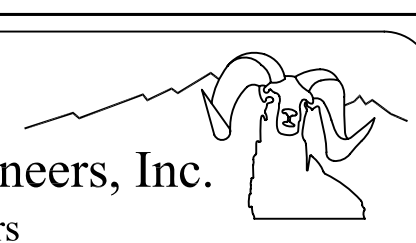

Bighorn Consulting Engineers, Inc.
 Mechanical & Electrical Engineers
 569 S. Westgate Dr., Suite 1
 Grand Junction, CO 81505
 phone: 970-241-8709, fax: 970-241-9514

UNIVERSITY VILLAGE APARTMENTS
ELECTRICAL ONE LINE DRAWINGS
 2304 NORTH 17TH STREET
 GRAND JUNCTION, COLORADO

DATE:	ISSUED FOR:
06/07/10	PERMIT

DATE:	06/07/10
JOB NO.:	104079
DRAWN BY:	BRE
CHECKED BY:	BRE
SCALE:	AS SHOWN
SHEET NUMBER:	E1-2